


ELECTRICAL PROVIDED BY OTHERS

ELECTRICAL PROVIDED BY NOISE BARRIERS

MOTOR SIZING CHART	
DOOR SIZE (UP TO)	MOTOR HORSEPOWER
36 SQ. FT.	.75
72 SQ. FT.	1.0
145 SQ. FT.	2.0
218 SQ. FT.	3.0
290 SQ. FT.	5.0
360 SQ. FT.	5.0

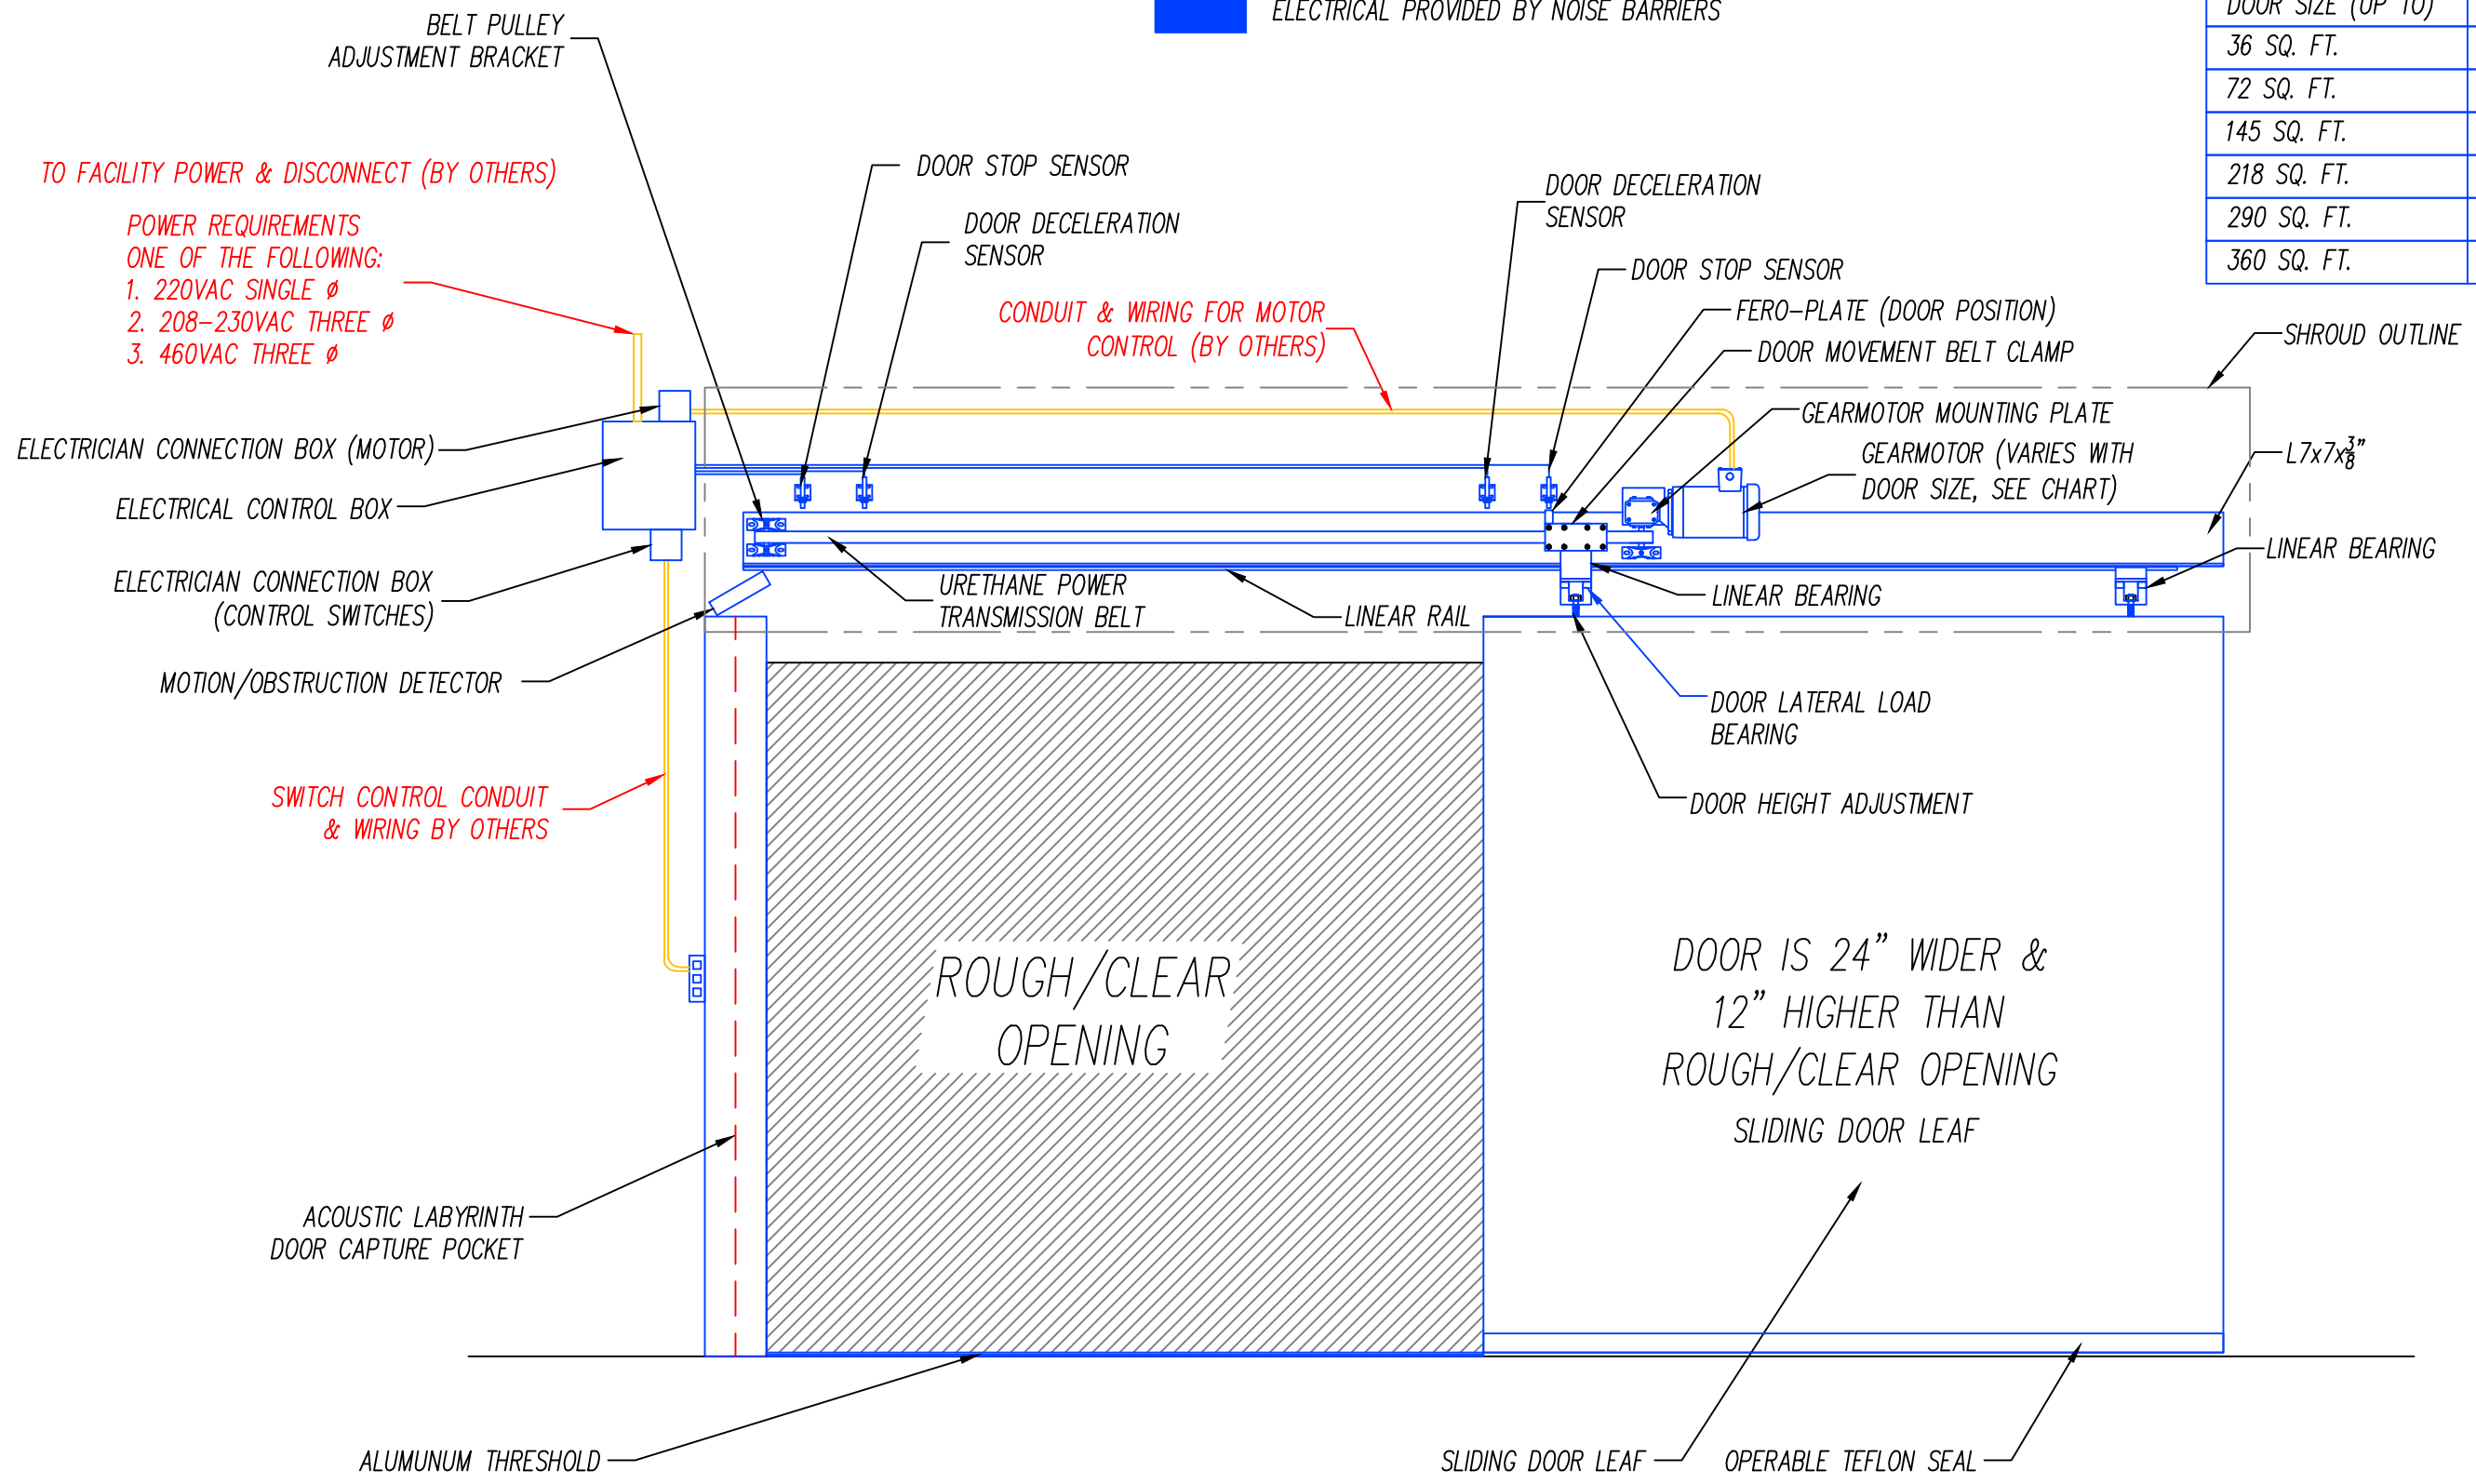

ELECTRICAL LAYOUT/SCOPE

PROPRIETARY
 THIS DESIGN AND DRAWING IS THE EXCLUSIVE PROPERTY OF NOISE BARRIERS, LLC. AND IS SUBMITTED AS CONFIDENTIAL INFORMATION IN CONNECTION WITH YOUR INQUIRY. IT MUST NOT BE USED FOR ANY OTHER PURPOSES, NOR CAN IT BE COPIED OR LOANED WITHOUT WRITTEN PERMISSION. UPON REQUEST IT MUST BE RETURNED IMMEDIATELY.

DESCRIPTION	DATE	BY
ORIGINAL/INITIAL	10/6/15	MD

DESCRIPTION		
NOISE BARRIERS, LLC QUIET SLIDE SERIES SLIDING DOOR		
CUSTOMER		
DRAWN BY	SCALE	PROJECT NO.
MDD	N.T.S.	XXXX
DATE	SHEET	OF
11/03/2015	2	3

Noise Barriers, LLC
 2001 Kelley Ct.
 Libertyville, IL 60048
 Phone: (847) 843-0500
 Fax: (847) 843-0501
www.noisebarriers.com